

Mallory Residence Kitchen Renovation



PENDANT LIGHT OVER ISLAND



PAINT

CABINET CROWN MOLDING



KITCHEN FAUCET

BACKSPLASH



UNDERMOUNT SINK



COUNTERTOP



FABRICS FOR DINING BENCH AND CUSTIONS



DINING BENCH



CABINET PULL



CABINET DOORS



EATING BAR STOOL



HARDWOOD FLOORING





Wall Tile Backsplash



Wall paint



Lighting



Accent Wall Wallpaper



Sink



Faucet



Countertop



Cabinet Pull



Cabinet Door



Upholstery Fabric



Bar Stool




Luxury Vinyl Flooring

Residential Kitchen Presentation Board

Mood board for new apartment renovation for client - Bachelor living in downtown loft in Edmonton



fluent

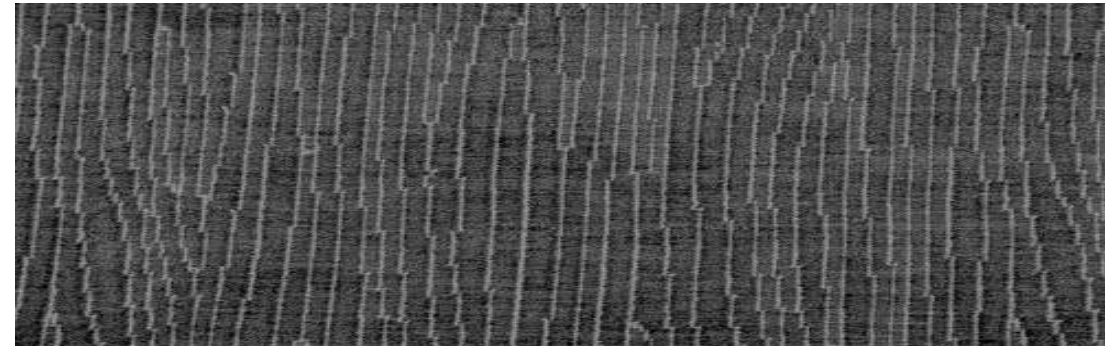



consultants

notes

revisions

no. date description

project title

MORGAN
RESIDENCE

sheet title

DEMOLITION PLAN

designed by: E.T.E.

checked by:

drawn by: INDIGO LANDRY

date: APRIL 23, 2024

course: IND1200

class: AD1

instructor: S. STENHAUER


scale: 1/4" = 1'-0"

sheet: SHEET 1 OF 9

project no. drawing no.

cut file

A1.1

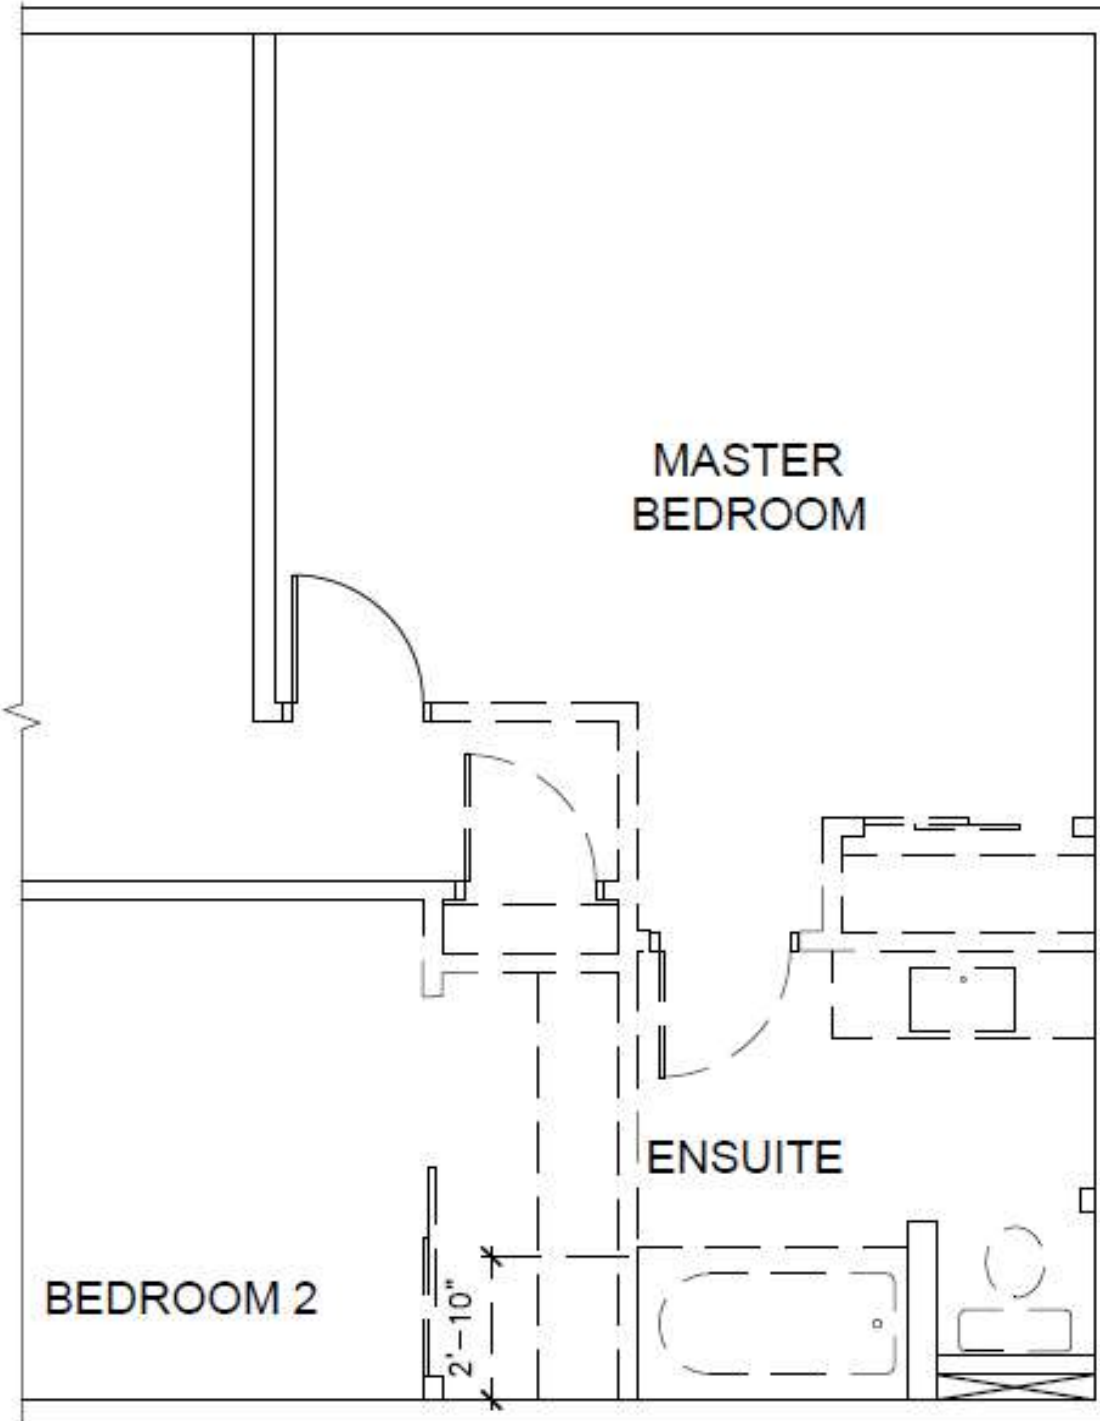

LEGEND

--- DENOTES WALL TO BE REMOVED

... DENOTES MILLWORK, DOORS & PLUMBING FIXTURES TO BE REMOVED

NOTES:

- REPAIR DAMAGE TO CONNECTING WALLS
- REMOVE EXISTING FLOORING
- CARE SHOULD BE TAKEN IN THE REMOVAL OF DOORS AND PLUMBING
- RETAIN UNDAMAGED ITEMS FOR SALVAGE AND DONATION

EXTERIOR WALLS 6 1/2" TH.
 INTERIOR WALLS 4 1/2" TH. U.N.O.
 CEILING HEIGHT 8'-0" A.F.F.

1

DEMOLITION PLAN

A1.1

SCALE: 1/4" = 1'-0"



consultants:

notes:

revisions:

no.

date

description

project title

sheet title

designed by:

checked by:

drawn by:

date:

course:

class:

instructor:

scale:

sheet:

project no.

drawing no.

MORGAN
RESIDENCE

NEW PLAN

VELORE

INDIGO LANDRY

APRIL 22, 2024

INDT1200


AD1

S. STEINHAUER

1/4" = 1'-0"

SHEET 2 OF 9

A1.2

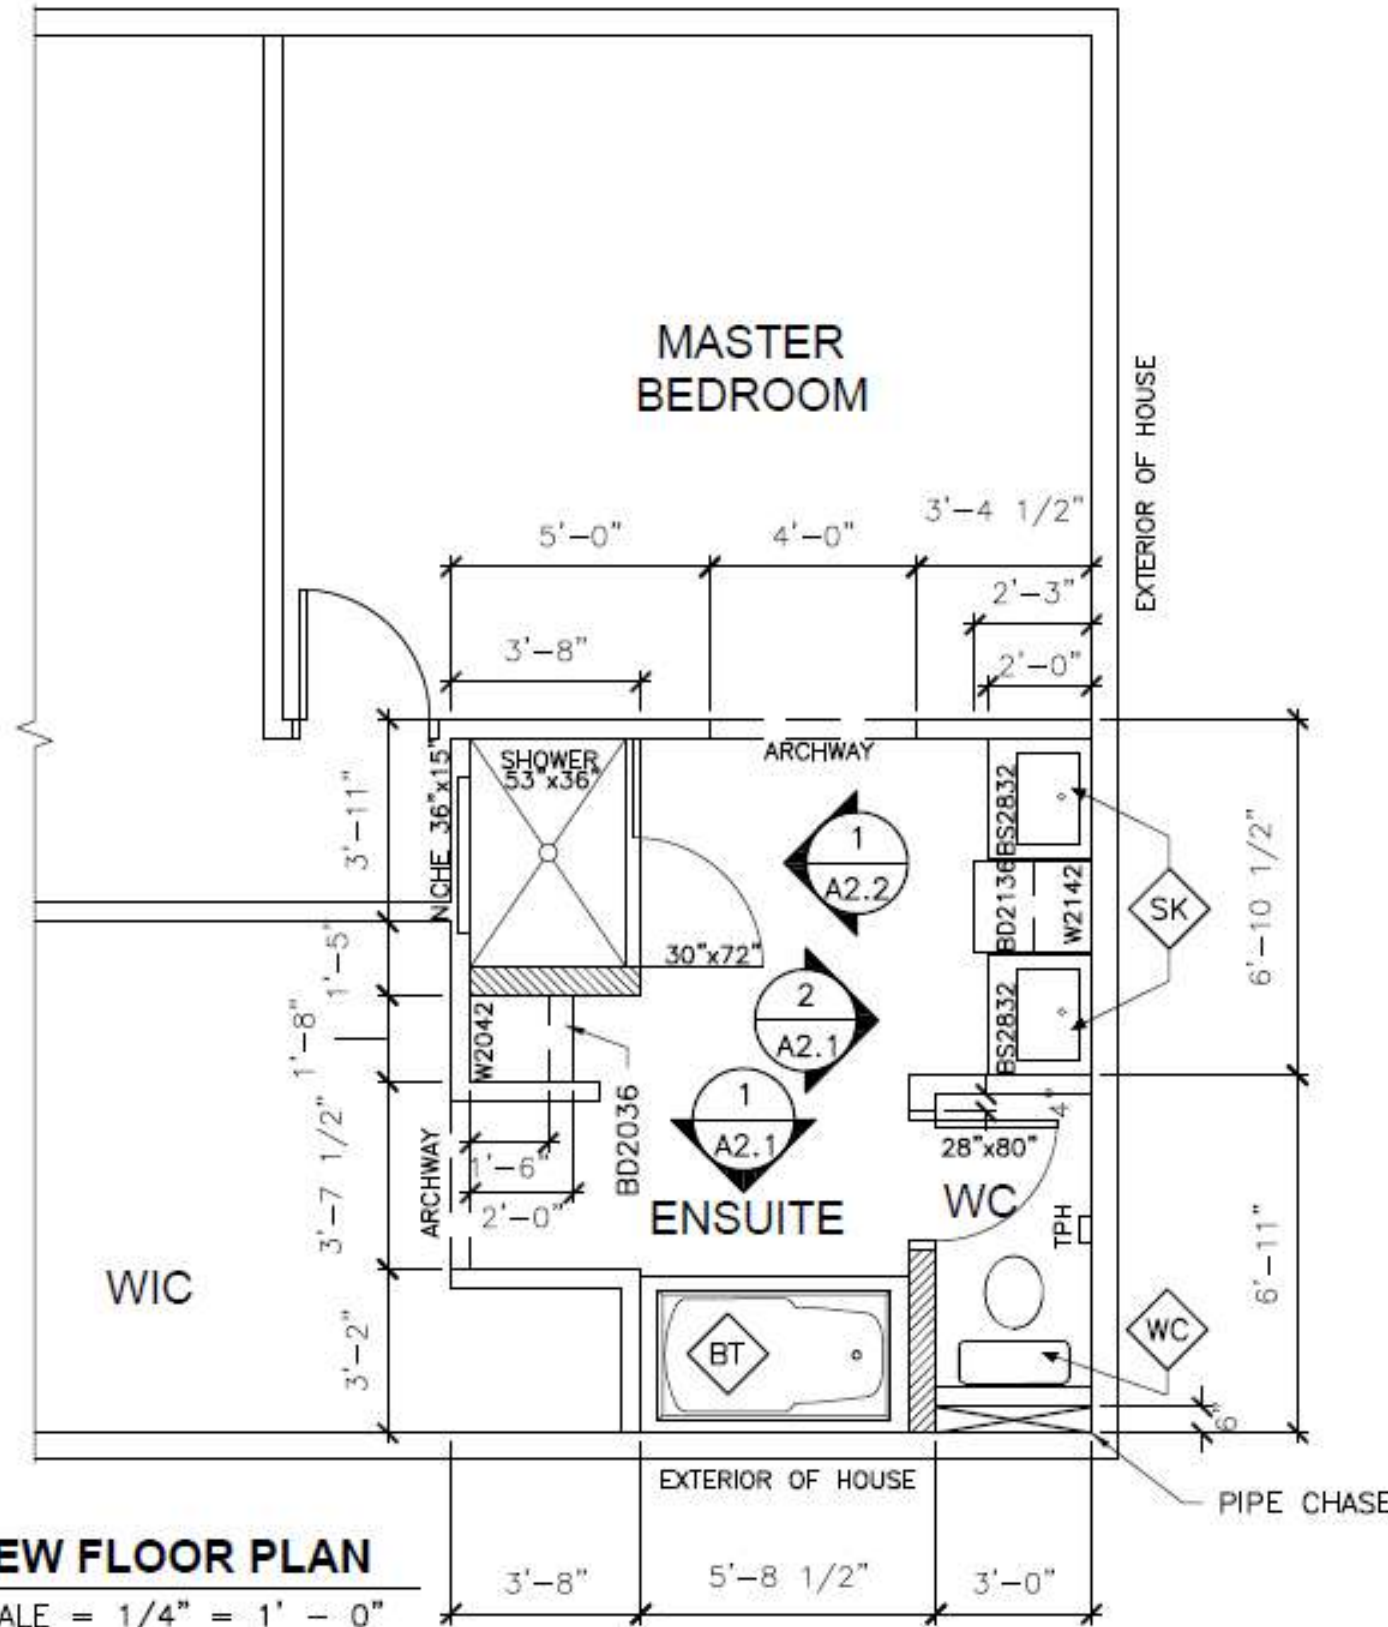

LEGEND



DENOTES 6 1/2" TH. PLUMBING WALL

NOTES:

EXTERIOR WALLS 6 1/2" TH.
INTERIOR WALLS 4 1/2" TH. U.N.O.
CEILING HEIGHT 8'-0" A.F.F.

1 NEW FLOOR PLAN
A1.2 SCALE = 1/4" = 1' - 0"



SCHOOL OF SUSTAINABLE BUILDING
AND ENVIRONMENTAL MANAGEMENT
ARCHITECTURAL TECHNOLOGY

consultants:

notes:

revisions:

no.	date	description

project title

MORGAN
RESIDENCE

sheet title

FINISH PLAN

designed by: DESIGNER

checked by:

drawn by: INDIGO LANDRY

date: APRIL, 23, 2024

course: INDT1200

class: A01

instructor: S. STEINHAUER

scale: 1/4" = 1'-0"

sheet: SHEET 3 OF 9

project no.

drawing no.

cad file

A1.3



FINISH LEGEND:

T3 12"x24" PORCELAIN TILE

T1 1"x1" MOSAIC TILE

SS QUARTZ SOLID SURFACE

TR1 SCHLUTER TRANSITION 1

NOTES:

FLOORING TO EXTEND 1" UNDER TOE KICK OF VANITY CABINETS.


ALL BASEBOARDS TO BE 6"x24" TILE W/TR2

ARROWS ON FLOORING INDICATE DIRECTION OF INSTALLATION

ARROWS IN SHOWER INDICATE SLOPE (2")

ALL WALLS TO BE P1, ALL DOORS & TRIM TO BE P2

COUNTERTOPS TO BE 1-1/2" TH, SOLID SURFACE,
TUB DECK & SHOWER CURB TO BE 1/2" TH.

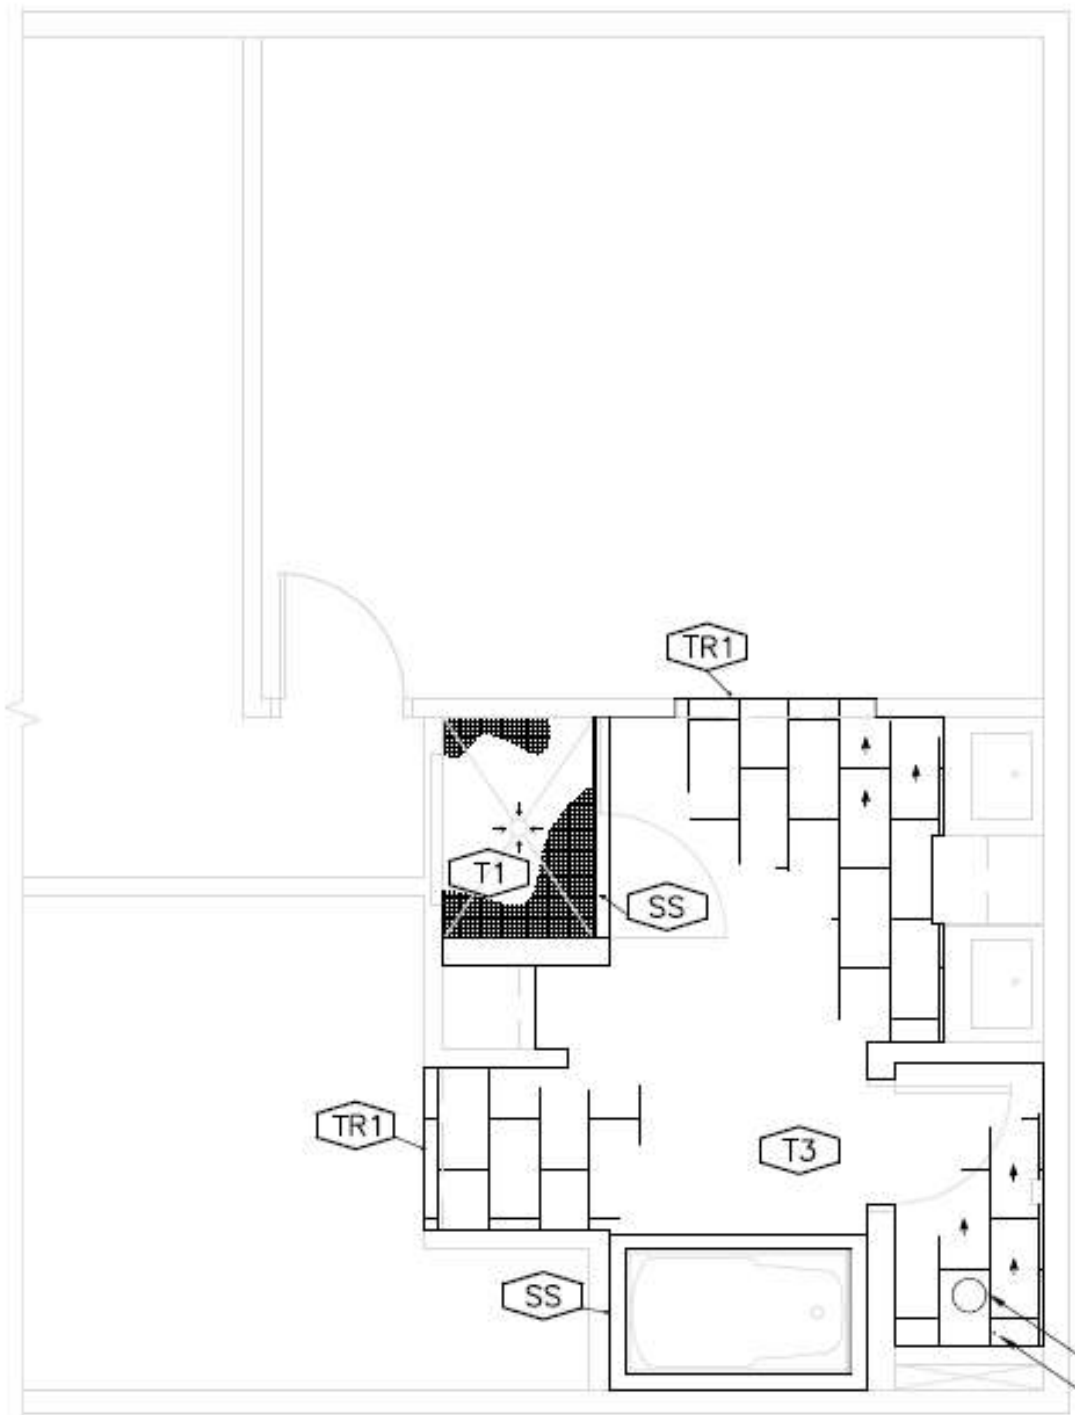

EXTERIOR OF HOUSE

EXTERIOR OF HOUSE

TOILET DRAIN
WATER SUPPLY

1 FINISH PLAN
A1.2 SCALE = 1/4" = 1' - 0"



consultants:

revisors:

revisions:

no. date description

project title

MORGAN RESIDENCE

sheet title

ELEVATIONS

designed by: (E.L.)

checked by:

drawn by: INDIGO LANDRY

date: APRIL 23, 2024

course: INDT1200

class: AD1

instructor: S. STEINHAUER

scale: 1/2" = 1'-0"


sheet: SHEET 4 OF 9

project no.

drawing no.

sheet title


A2.1

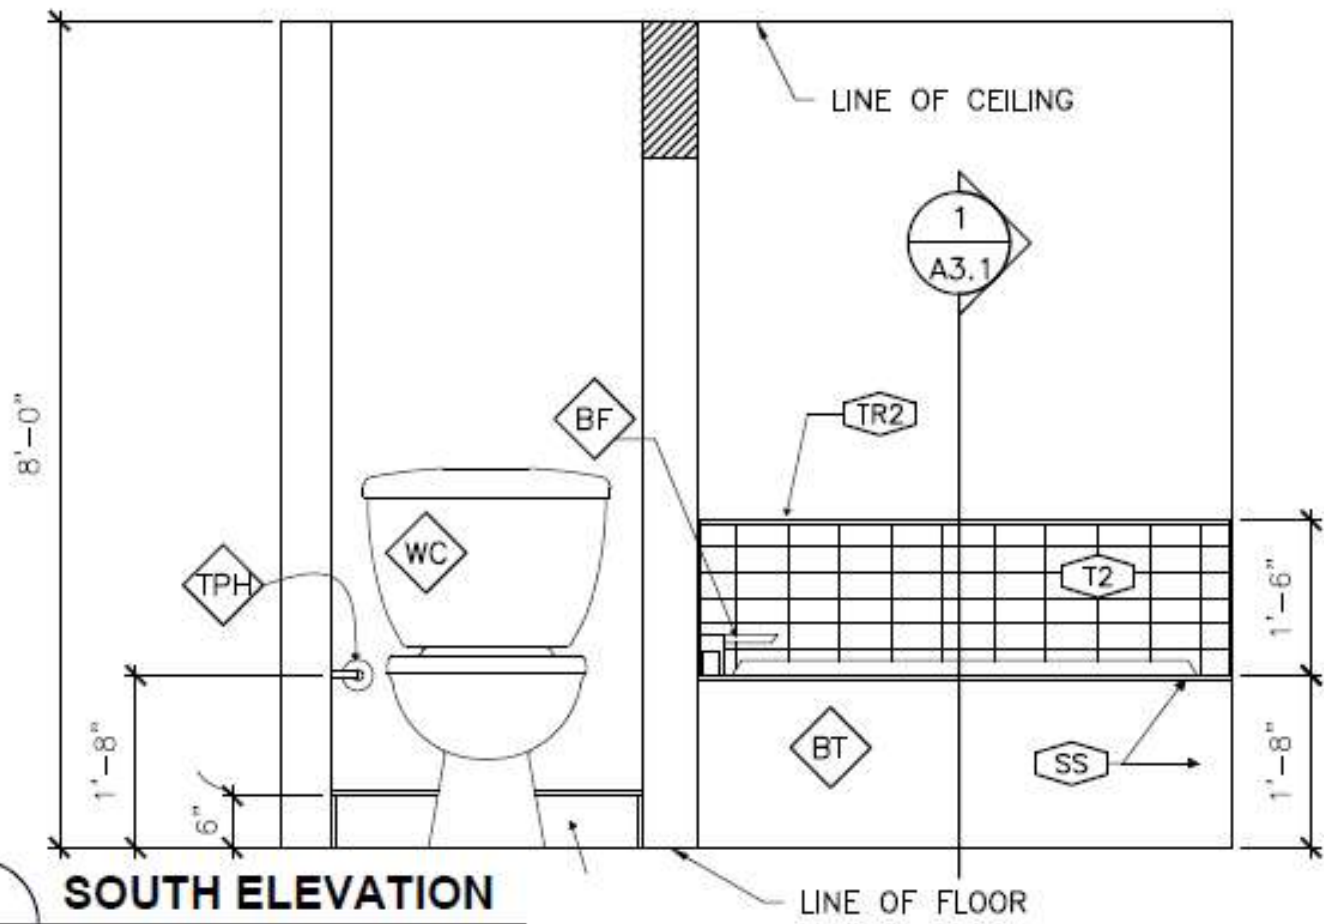

NOTES:
ALL WALLS TO BE P1 U.N.O

1 SOUTH ELEVATION

A2.1 SCALE = 1/2" = 1'-0"

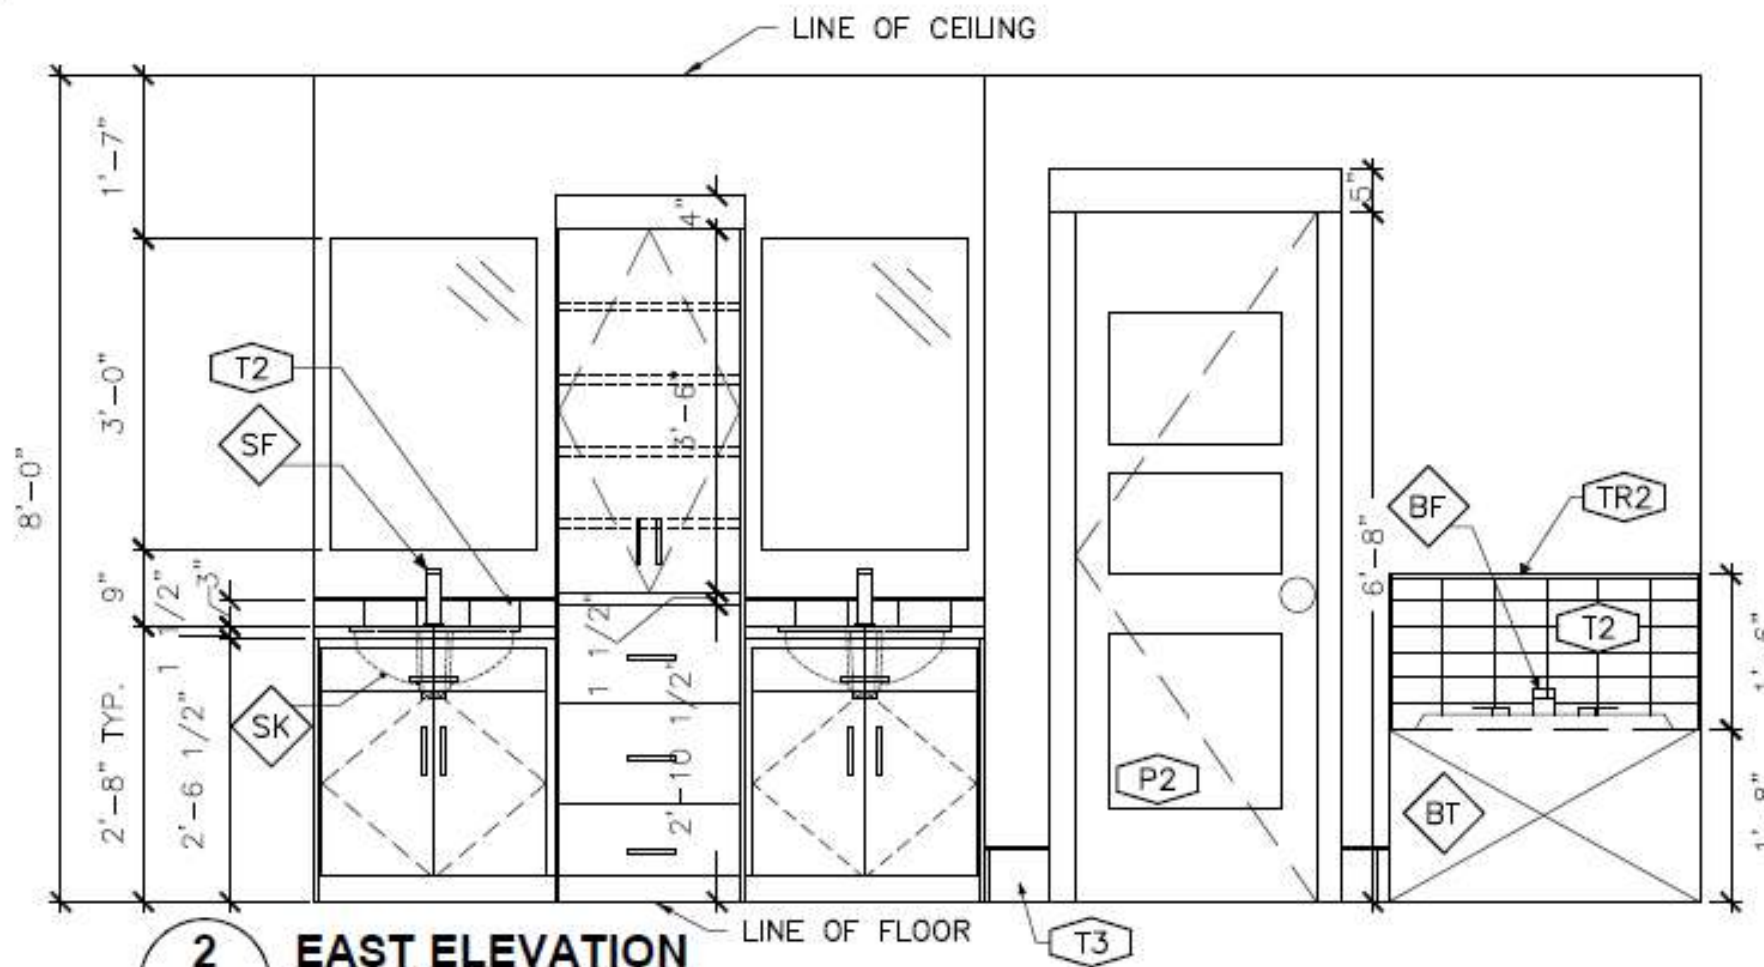

NOTES:

MIRRORS SHOWN ARE 24" WIDE AND CENTERED OVER SINKS

ALL WALLS TO BE P1 U.N.O

ALL DOORS & TRIM TO BE P2 U.N.O

2 EAST ELEVATION

A2.1 SCALE = 1/2" = 1'-0"



SCHOOL OF SUSTAINABLE BUILDING
AND ENVIRONMENTAL MANAGEMENT
ARCHITECTURAL TECHNOLOGY

consultants:

notes:

revisions:

no.

date

description

project title

MORGAN
RESIDENCE

sheet title

ELEVATIONS

designed by: DEIONE

checked by:

drawn by: INDIGO LANDRY

date: APRIL 23, 2024

course: INDT1200

class: A01

instructor: S. STEINHAUER

scale: 1/2" = 1'-0"

sheet: SHEET 5 OF 9

project no.

drawing no.


cad file

A2.2

NOTES:

ALL WALLS TO BE P1 U.N.O

ALL DOORS & TRIM TO BE P2 U.N.O

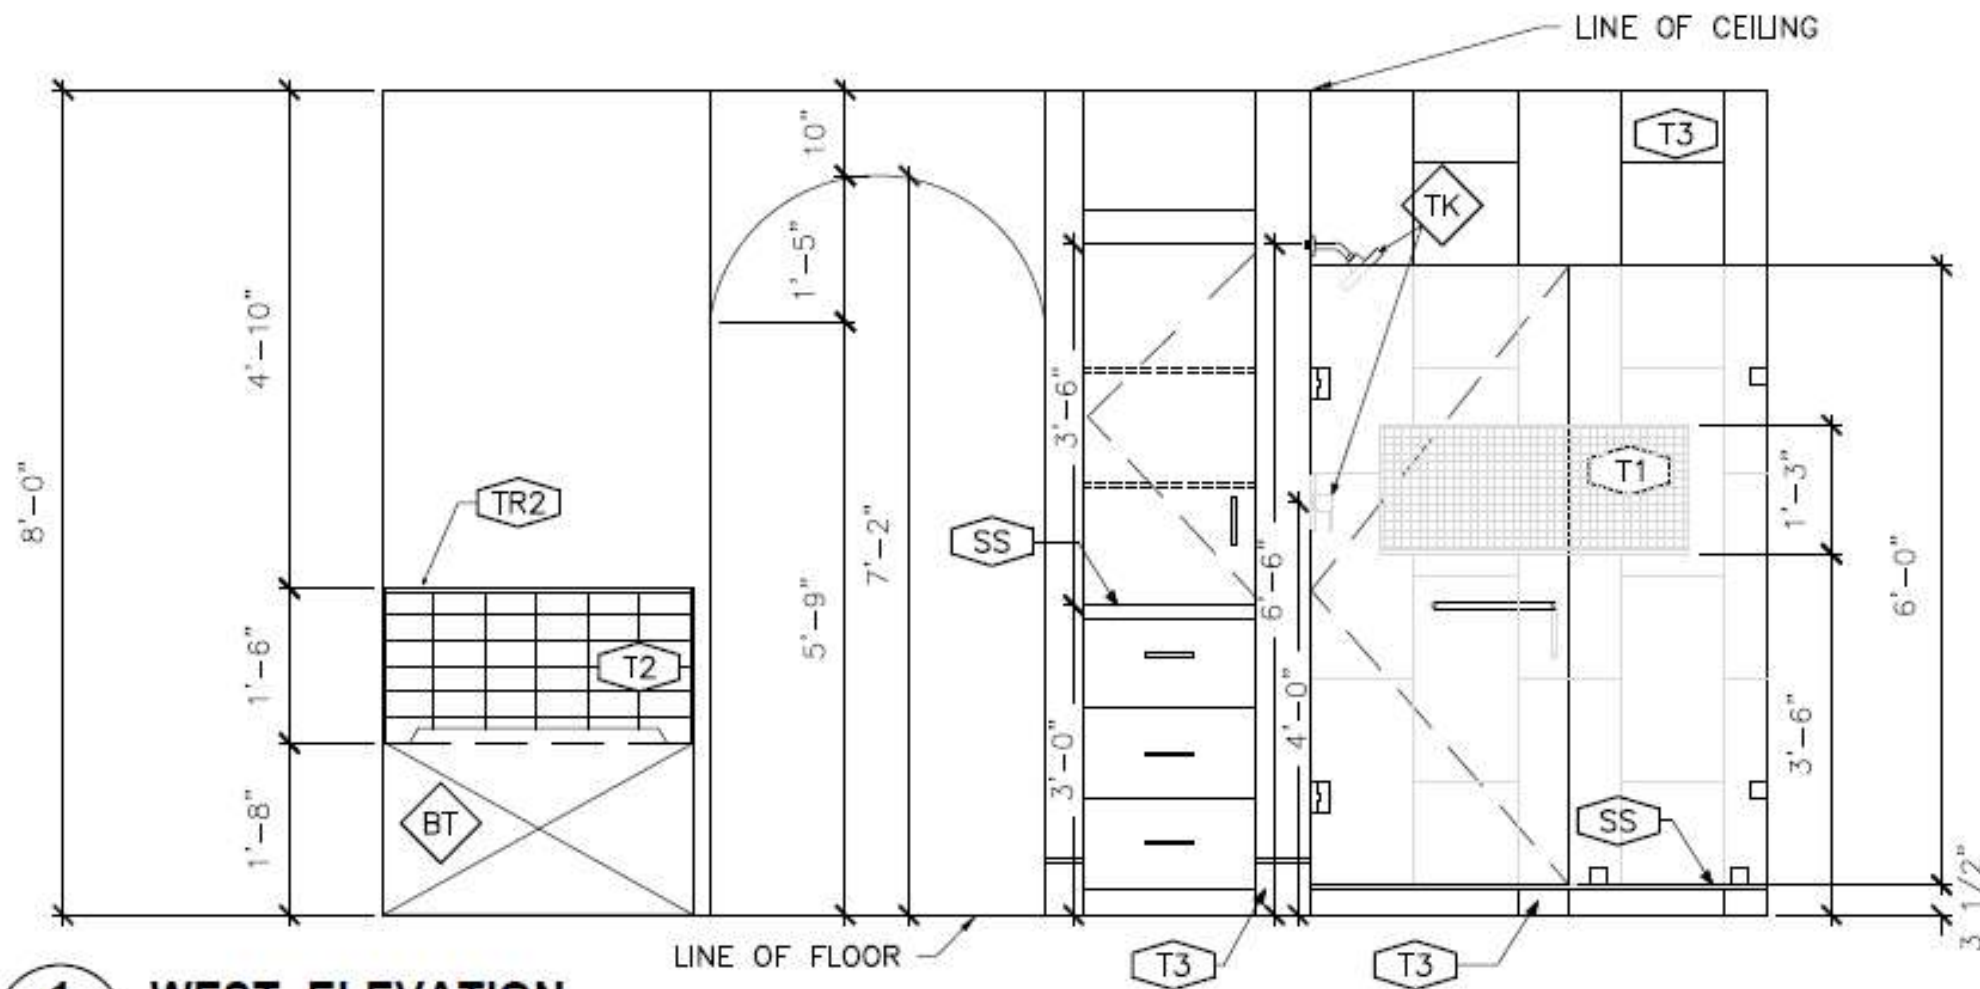

1 WEST ELEVATION

A2.2 SCALE = 1/2" = 1'-0"



SCHOOL OF SUSTAINABLE BUILDING
AND ENVIRONMENTAL MANAGEMENT
ARCHITECTURAL TECHNOLOGY

consultants

revisions

no.

date

description

project title

MORGAN
RESIDENCE

sheet title

BATH SECT. & DETAIL

designed by: DELORE

checked by:

drawn by: INDIGO LANDRY

date: APRIL 23, 2024

course: IND1200

class: AD1

instructor: S. STENHAUER

scale: VARIES


sheet: SHEET 6 OF 9

project no.

drawing no.

cut file

A3.1

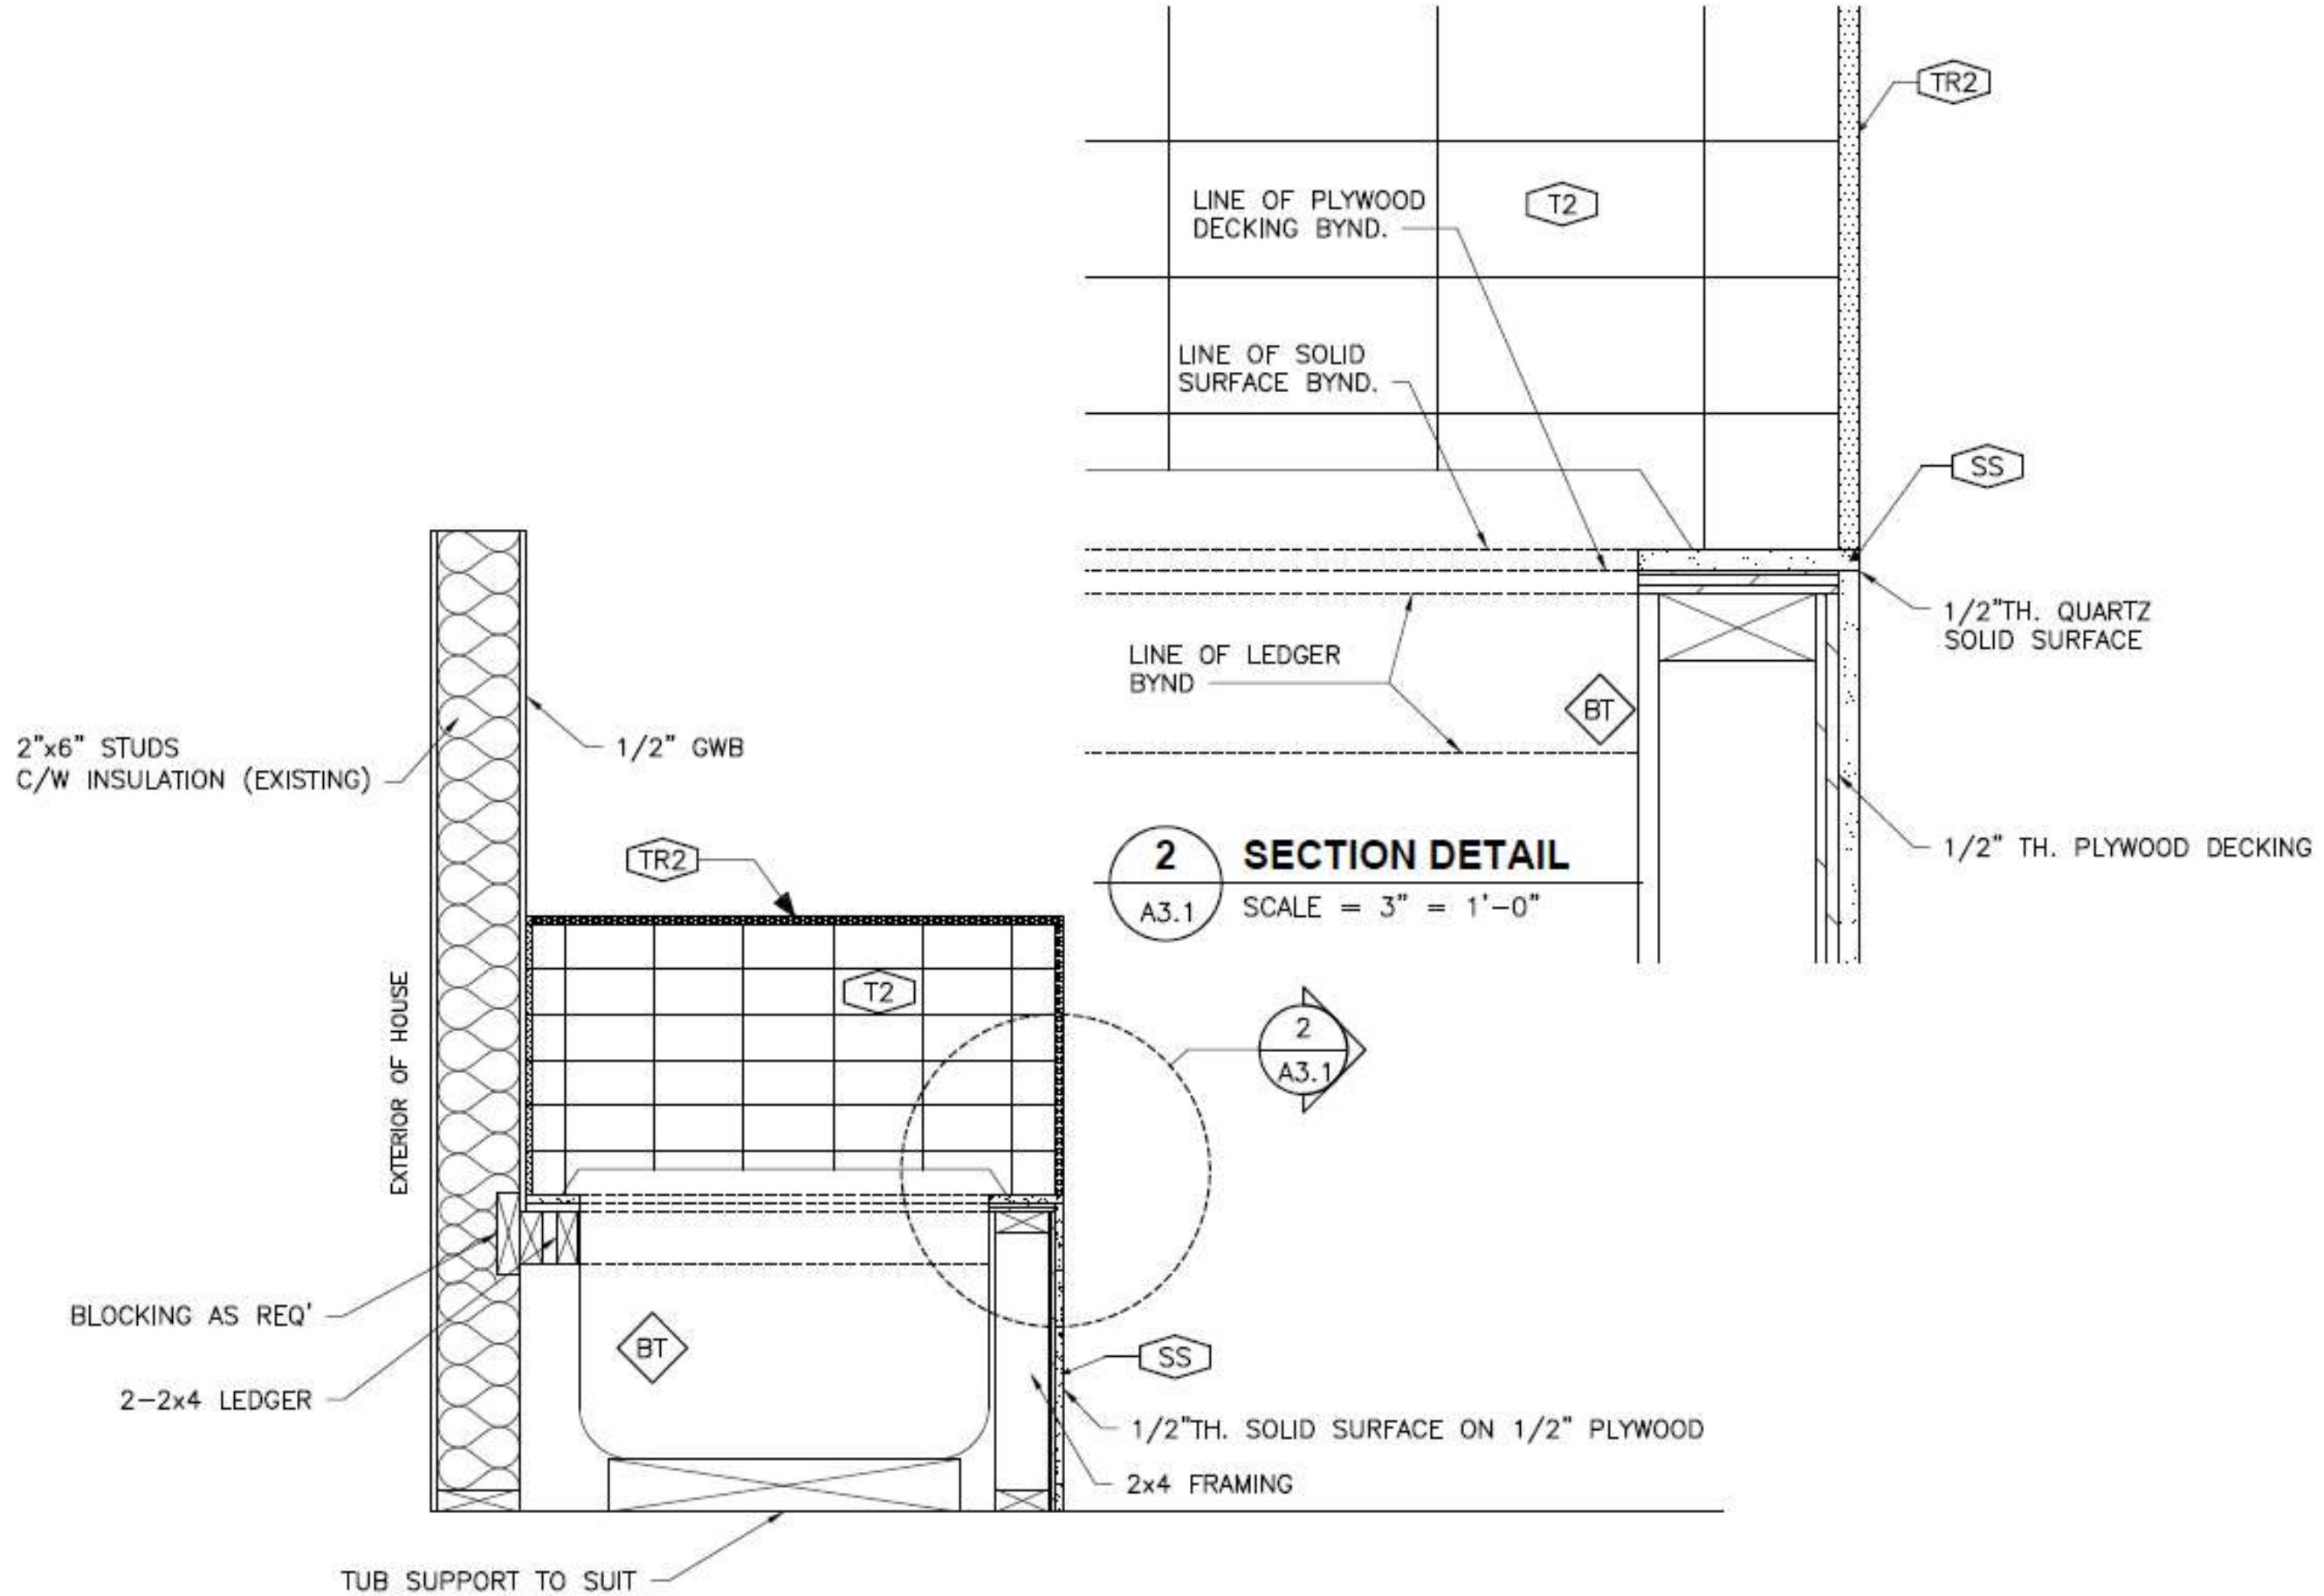

2 SECTION DETAIL
A3.1 SCALE = 3" = 1'-0"

1 BATH SECTION
A3.1 SCALE = 1" = 1'-0"



SCHOOL OF SUSTAINABLE BUILDING
AND ENVIRONMENTAL MANAGEMENT
ARCHITECTURAL TECHNOLOGY

consultants:

notes:

revisions:

no.	date	description

project title

**MORGAN
RESIDENCE**

sheet title

**CABINET
SCHEDULE**

designed by: DE JONGE

checked by:

drawn by: INDIGO LANDRY

date: APRIL 23, 2024

course: INDT1200

class: AD1

instructor: S. STEINHAUER

scale:

sheet: SHEET 7 OF 9

project no.

drawing no.

cad file

A4.1

CABINET SCHEDULE

TAG	CAB. TYPE	ROOM	INSERTS	HINGE	SIZE	REMARKS
BS2832	BASE-SINK	ENSUITE	N/A	CONCEALED	28W X 32 1/2"H X 24"D	1 FALSE DRAWER, 2 DOOR
BD2136	BASE	ENSUITE	N/A	N/A	22"W X 36"H X 27"D	3 DRAWER, 1/2" TH. GABLE PANEL EACH SIDE
BD1836	BASE	ENSUITE	N/A	N/A	18"W X 36"H X 24"D	3 DRAWER
W2142	WALL	ENSUITE	3 SHELVES, ADJ PIN AND POST	CONCEALED	21"W X 42"H X 12"D	2 DOOR, 1/2" TH. GABLE PANEL EACH SIDE
W1842	WALL	ENSUITE	2 SHELVES, ADJ PIN AND POST	CONCEALED	18"W X 42"H X 18"D	1 DOOR

NOTES:

COUNTERTOP TO BE 1-1/2" TH. CAESARSTONE QUARTZ, 4011 CLOUDBURST CONCRETE

ALL PULLS TO BE RICHELIEU, CONTEMPORARY STAINLESS STEEL PULL-520, BP520128195, BRUSHED NICKEL FINISH

ALL CABINETS TO BE CUSTOM, FLUSH OVERLAY, FRAMELESS STYLE

CABINET DOORS, DRAWER FRONTS, FILLERS (1/2" TH.), AND CROWN MOULDING TO BE FLAT SLAB MDF WITH F1 FINISH

INTERIORS OF CABINET BOXES TO BE MDF WITH F2 FINISH

EXTERIORS OF CABINETS TO BE MDF WITH F3 FINISH

FINISH SCHEDULE

TAG	MATER.	MANUF.	CODE #	COLOR	FINISH	COMMENTS
T1	MOSAIC TILE	DATILE	KEYSTONES DK14	MOONLIGHT	N/A	1"X1", 1/4" TH. APPLIED IN 1 SQ.FT SHEETS
T2	CERAMIC TILE	DATILE	RITTENHOUSE SQUARE 790	ARCTIC WHITE 190	MATTE	3"X6" X 5/16" TH.
T3	PORCELAIN TILE	ALPI	ALGR160	GRIGIO	GLAZED	11 1/4"X 23 3/4"X 5/16" TH.
SS	QUARTZ	CAESARSTONE	4011	CLOUDBURST CONCRETE	N/A	1-1/2"TH. FOR COUNTER APPLICATIONS & 1/2" TH. FOR ALL OTHER APPLICATIONS
P1	PAINT	BENJAMIN MOORE	HC-144	PALLADIAN BLUE	EGGSHELL	ALL WALLS
P2	PAINT	BENJAMIN MOORE	OC-149	DECORATORS WHITE	EGGSHELL	TRIM AND DOOR
F1	LAQUER	N/A	N/A	CLOUDBURST	MATTE	CABINET DOORS, TRIM, CROWN MOULDING, AND FILLERS
F2	MELAMINE	N/A	N/A	WHITE	MATTE	INTERIOR OF CABINET BOX, AND SHELVING
F3	MELAMINE	RICHELEIU	1761	MOONLIGHT	MATTE	EXTERIOR OF CABINET BOX
TR1	SCHLUTER TRANSITION	SCHLUTER	E 80 EB	N/A	BRUSHED STAINLESS STEEL	5/16"TH. TRANSITION, HARDWOOD TO T3
TR2	SCHLUTER TRANSITION	SCHLUTER	A 80 ATGB	N/A	BRUSHED NICKLE	5/16"TH. TRANSITION, T2 & T3 TO WALL

NOTES:

ALL BASEBOARDS TO BE T3 CUT DOWN TO 6"HX24"W, C/W TR2

ALL GROUT LINES TO BE 1/8" TH. FOR T1, T2, AND T3

T1 AND T2 TO BE SET IN 1/4" TROWELED MORTAR

T3 TO BE SET IN 1/2" TROWELED MORTAR



SCHOOL OF SUSTAINABLE BUILDING
AND ENVIRONMENTAL MANAGEMENT
ARCHITECTURAL TECHNOLOGY

consultants

notes:

revisions:

no.	date	description

project title

**MORGAN
RESIDENCE**

sheet title

**FINISH
SCHEDULE**

designed by: DESIGNER

checked by:

drawn by: INDIGO LANDRY

date: APRIL 23, 2024

course: INDT1200

class: AD1

instructor: S. STEINHAUER

scale:

sheet: SHEET 8 OF 9

project no.

drawing no.

cad file

A4.2



SCHOOL OF SUSTAINABLE BUILDING
AND ENVIRONMENTAL MANAGEMENT
ARCHITECTURAL TECHNOLOGY

PLUMBING & ACCESSORIES SCHEDULE

TAG	ITEM	MANUF.	MODEL #	FINISH	SIZE	COMMENTS
BT	JETTED TUB. DROP-IN	HYDRO SYSTEMS	SOLO 5430	---	40 GALLON. 54"L x 30"W x 19-1/4"H	REQ. 20 AMP DEDICATED GFCI, INTEGRAL E-Z LEVEL PLATFORM. C/W PUMP
TK	90 DEGREE POSI-TEMP SINGLE-HANDLE SHOWER TRIM KIT	MOEN	TS2712 SERIES	STAINLESS STEEL	SHOWER HEAD FLANGE: 2-1/2"x 2-1/2" LEVER FLANGE: 6-7/16"W 4-1/2"H	---
SK	LADENA BATHROOM SINK	KOHLER	K-2214	WHITE	18-5/8"L x 12-1/4"W x 4-5/8"D	UNDERMOUNT INSTALLATION, DRAIN HOLE 1-3/4"φ
SF	90 DEGREE SINGLE-HANDLE LAVATORY FAUCET	MOEN	S6700	---	2-3/16"W x 7-5/16"H x 4-1/4"D	INCLUDES METAL POP-UP WASTE ASSEMBLY. TO BE INSTALLED THRU 1 HOLE 1-1/8" MIN. φ
BF	90 DEGREE TWO-HANDLE ROMAN TUB FAUCET TRIM	MOEN	TS903 SERIES	---	16-1/4"W x 4-3/4"H x 9"D	INCLUDES HOT AND COLD TEMPERATURE INDICATOR
TPH	TOILET PAPER HOLDER	AMERICAN STANDARD	7455230-295	BRUSHED NICKEL	6-11/16"W O.C. x 3-7/16" D	NO EXPOSED SET SCREWS
WC	CLASS FIVE DUAL FLUSH TOILET	KOHLER	K-3987	WHITE	18"W x 20-1/4"H x 27-3/4"D	TWO-PIECE, FLOOR MOUNT. ROUGH IN 12" FOR INSTALLATION

NOTES:

SHOWER DOOR TO BE COMPLETED WITH RICHELIEU ROUND TUBULAR HANDLE AND TOWEL-RACK COMBO: SDBM6X14BN, LOCATED AT 36" A.F.F.

2 SHOWER DOOR HINGES TO BE RICHELIEU GLASS-TO-WALL BRUSHED NICKEL SQUARE STYLE: SDGEN044-CH

4 SHOWER GLASS CLAMPS TO BE RICHELIEU GLASS-TO-WALL, BRUSHED NICKEL SQUARE STYLE: 8710290SB-140

consultants

notes:

revisions:

no.	date	description


project title
**MORGAN
RESIDENCE**

sheet title
**FINISH
SCHEDULE**


designed by: DESIGNER
checked by:
drawn by: INDIGO LANDRY
date: APRIL 23, 2024
course: INDT1200
class: AD1
instructor: S. STEINHAUER
scale:
sheet: SHEET 9 OF 9

project no. drawing no.


cad file **A4.3**

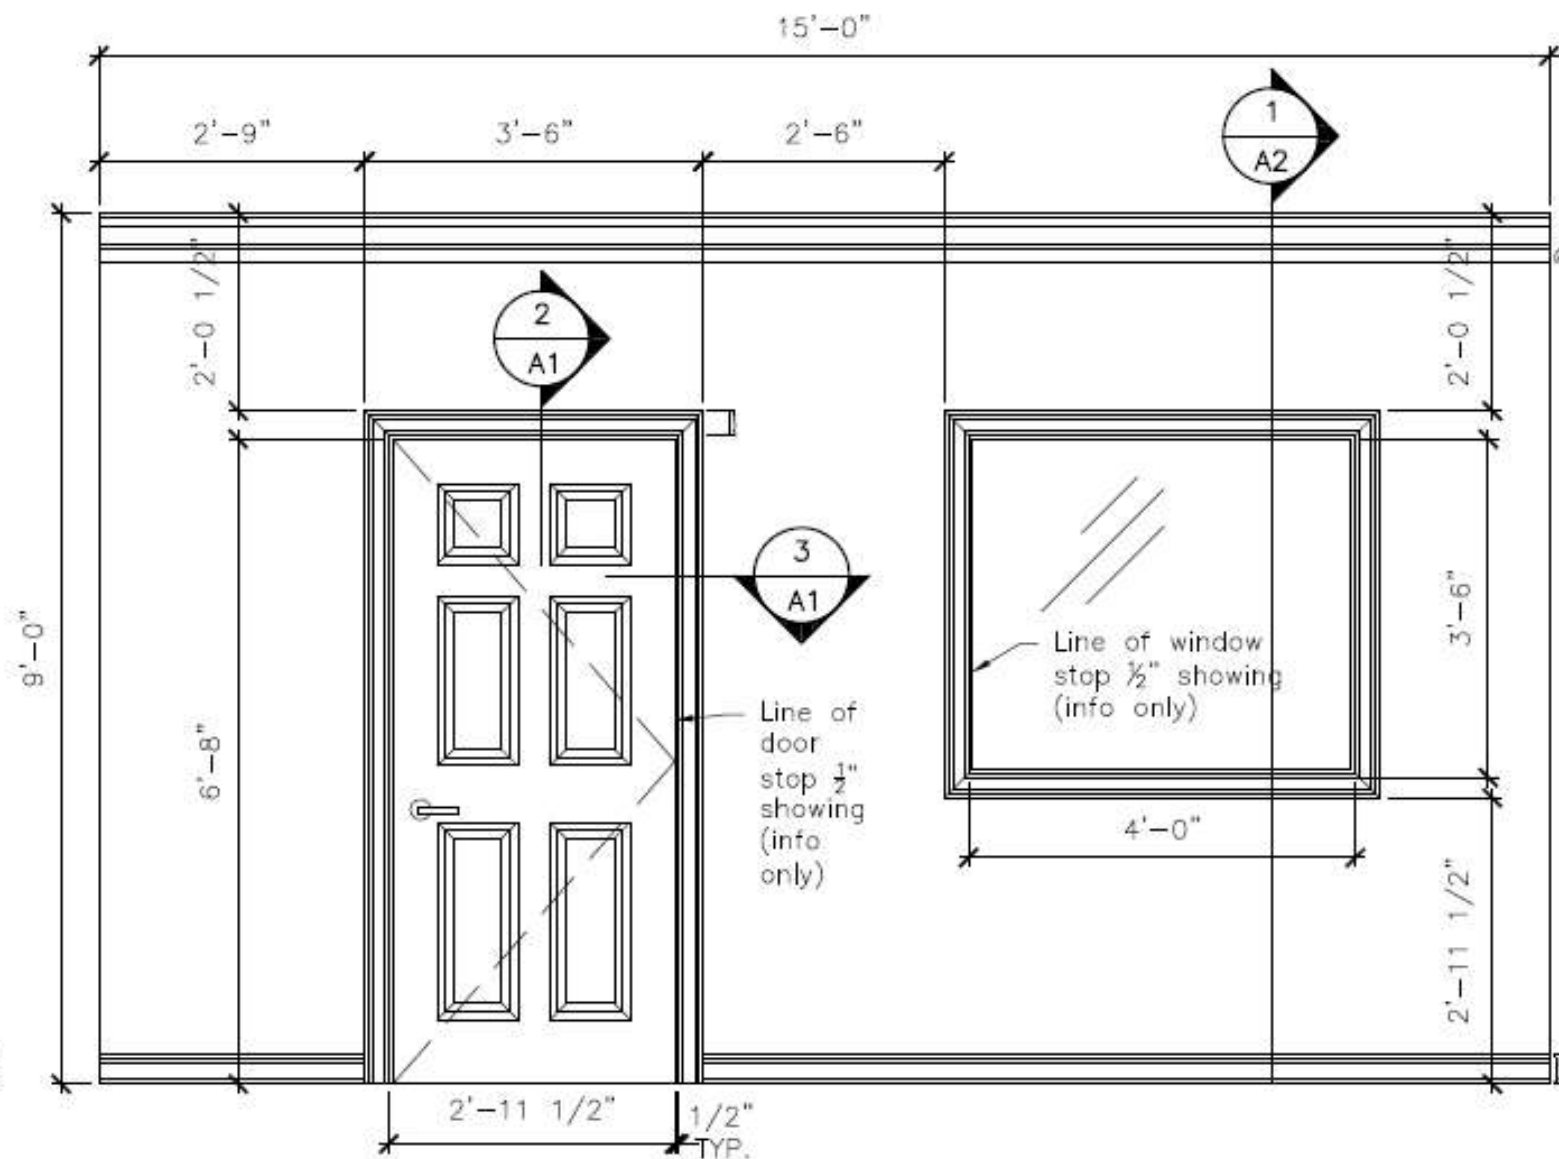

1 INTERIOR WALL ELEVATION
A1 SCALE: 1/2"=1'-0"

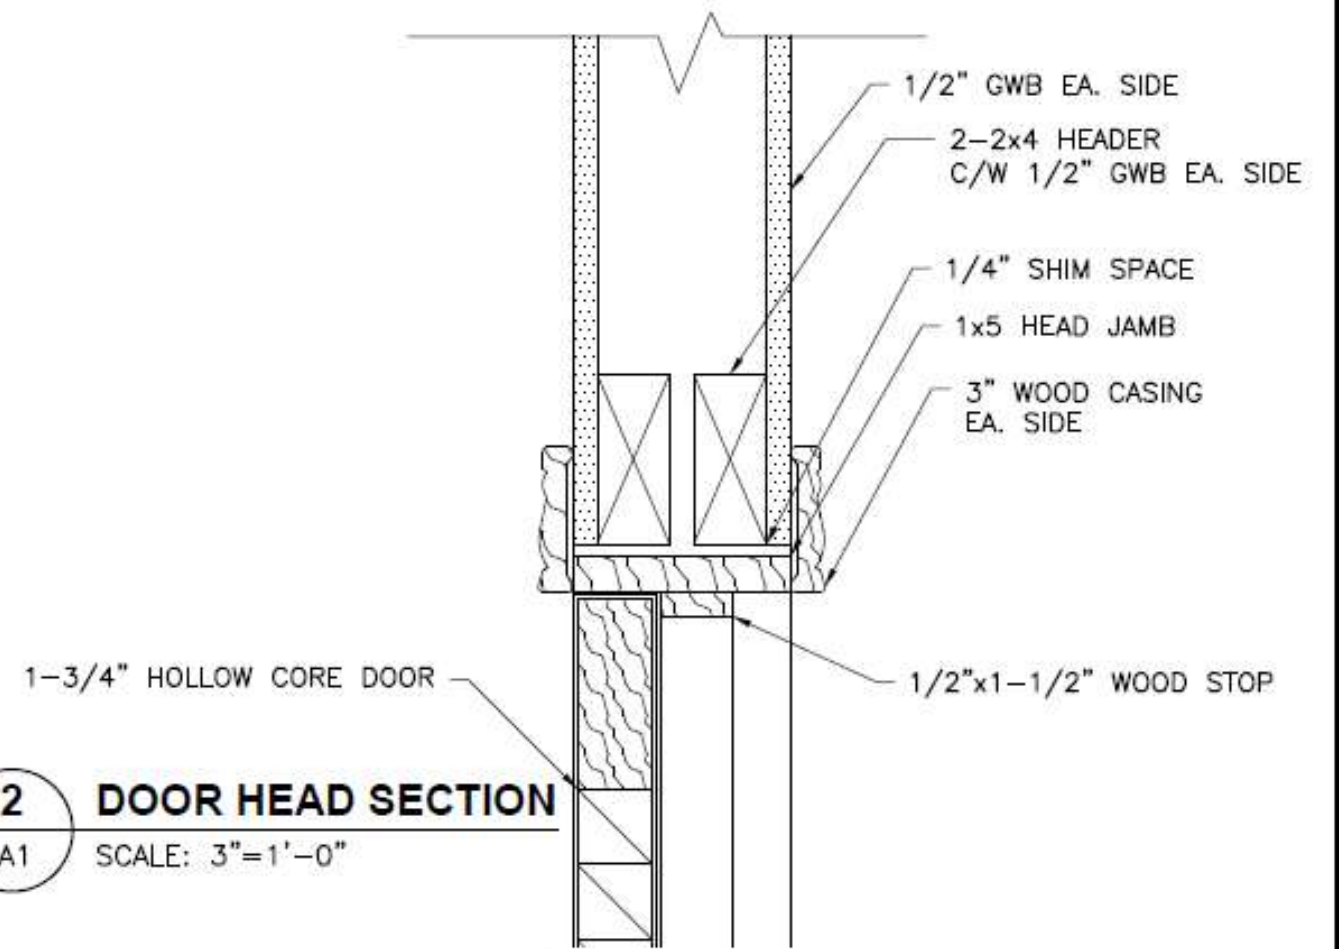

2 DOOR HEAD SECTION
A1 SCALE: 3"=1'-0"

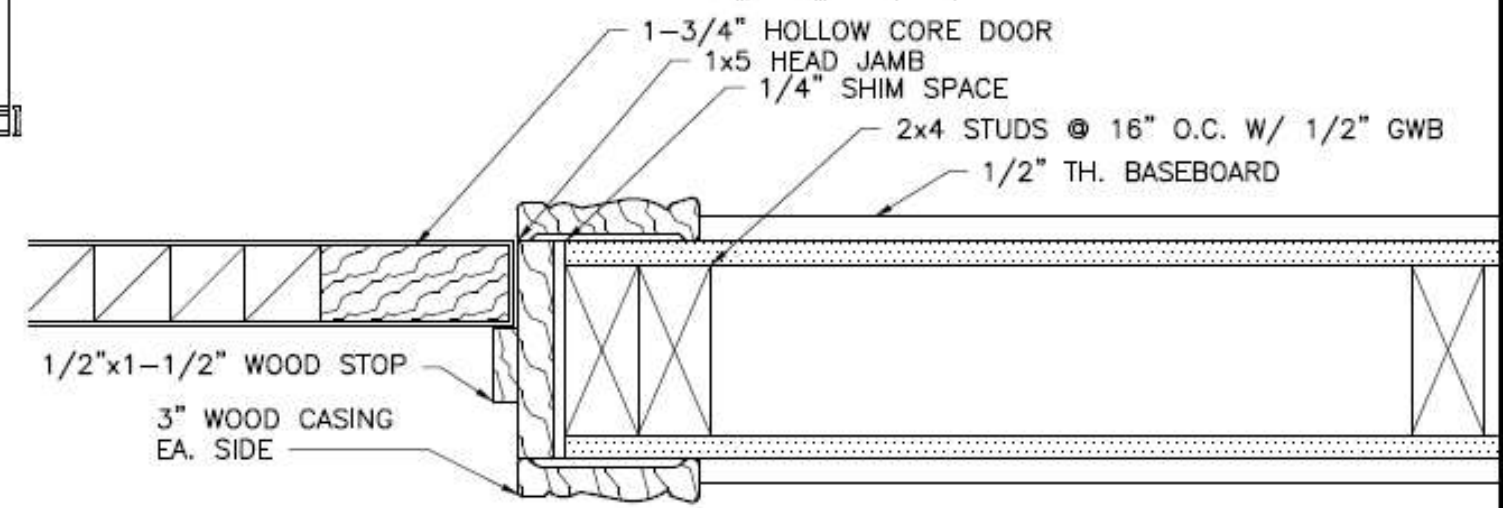

3 DOOR JAMB SECTION
A1 SCALE: 3"=1'-0"



SCHOOL OF SUSTAINABLE BUILDING AND ENVIRONMENT MANAGEMENT
ARCHITECTURAL TECHNOLOGY


project title	DOOR & WINDOW SECTION EX.
sheet title	ELEVATION & SECTIONS

designed by:	NAIT
drawn by:	INDIGO LANDRY
date:	FEB, 01, 2024
course:	INDT1200

class:	A01
instructor:	SHARLEEN STEINHAUER
scale:	VARIABLES
sheet:	1 of 2

notes:	
drawing no.	A1

cad file	
----------	--

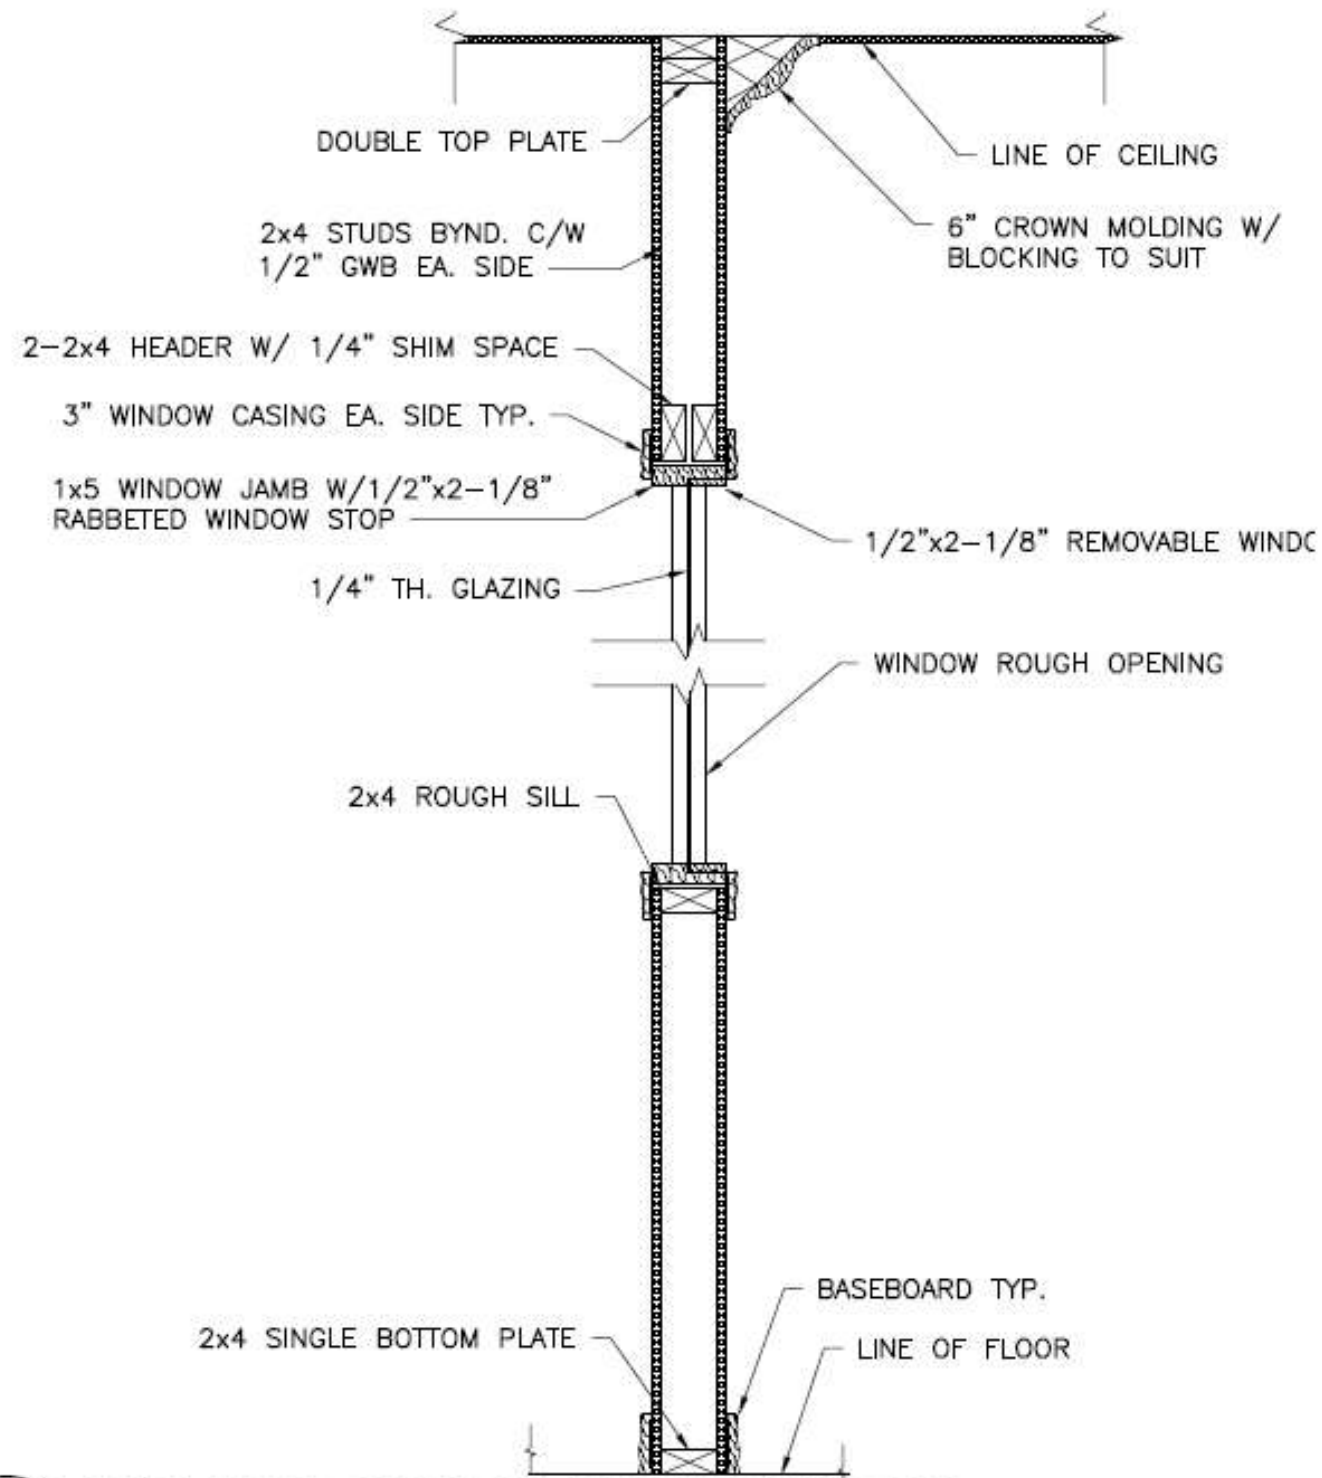

4 FULL WALL SECTION THROUGH WINDOW
 A2 SCALE: 1"=1'-0"

 SCHOOL OF SUSTAINABLE BUILDING AND ENVIRONMENT MANAGEMENT ARCHITECTURAL TECHNOLOGY	project title DOOR & WINDOW SECTION EX.	designed by: NAIT	class: A01	notes: drawing no. A2
	sheet title ELEVATION & SECTIONS	drawn by: INDIGO LANDRY	instructor: SHARLEEN STEINHAUER	
	date: FEB, 02, 2024	scale: 1" = 1'-0"		
	course: INDT1200	sheet: 1 of 2		